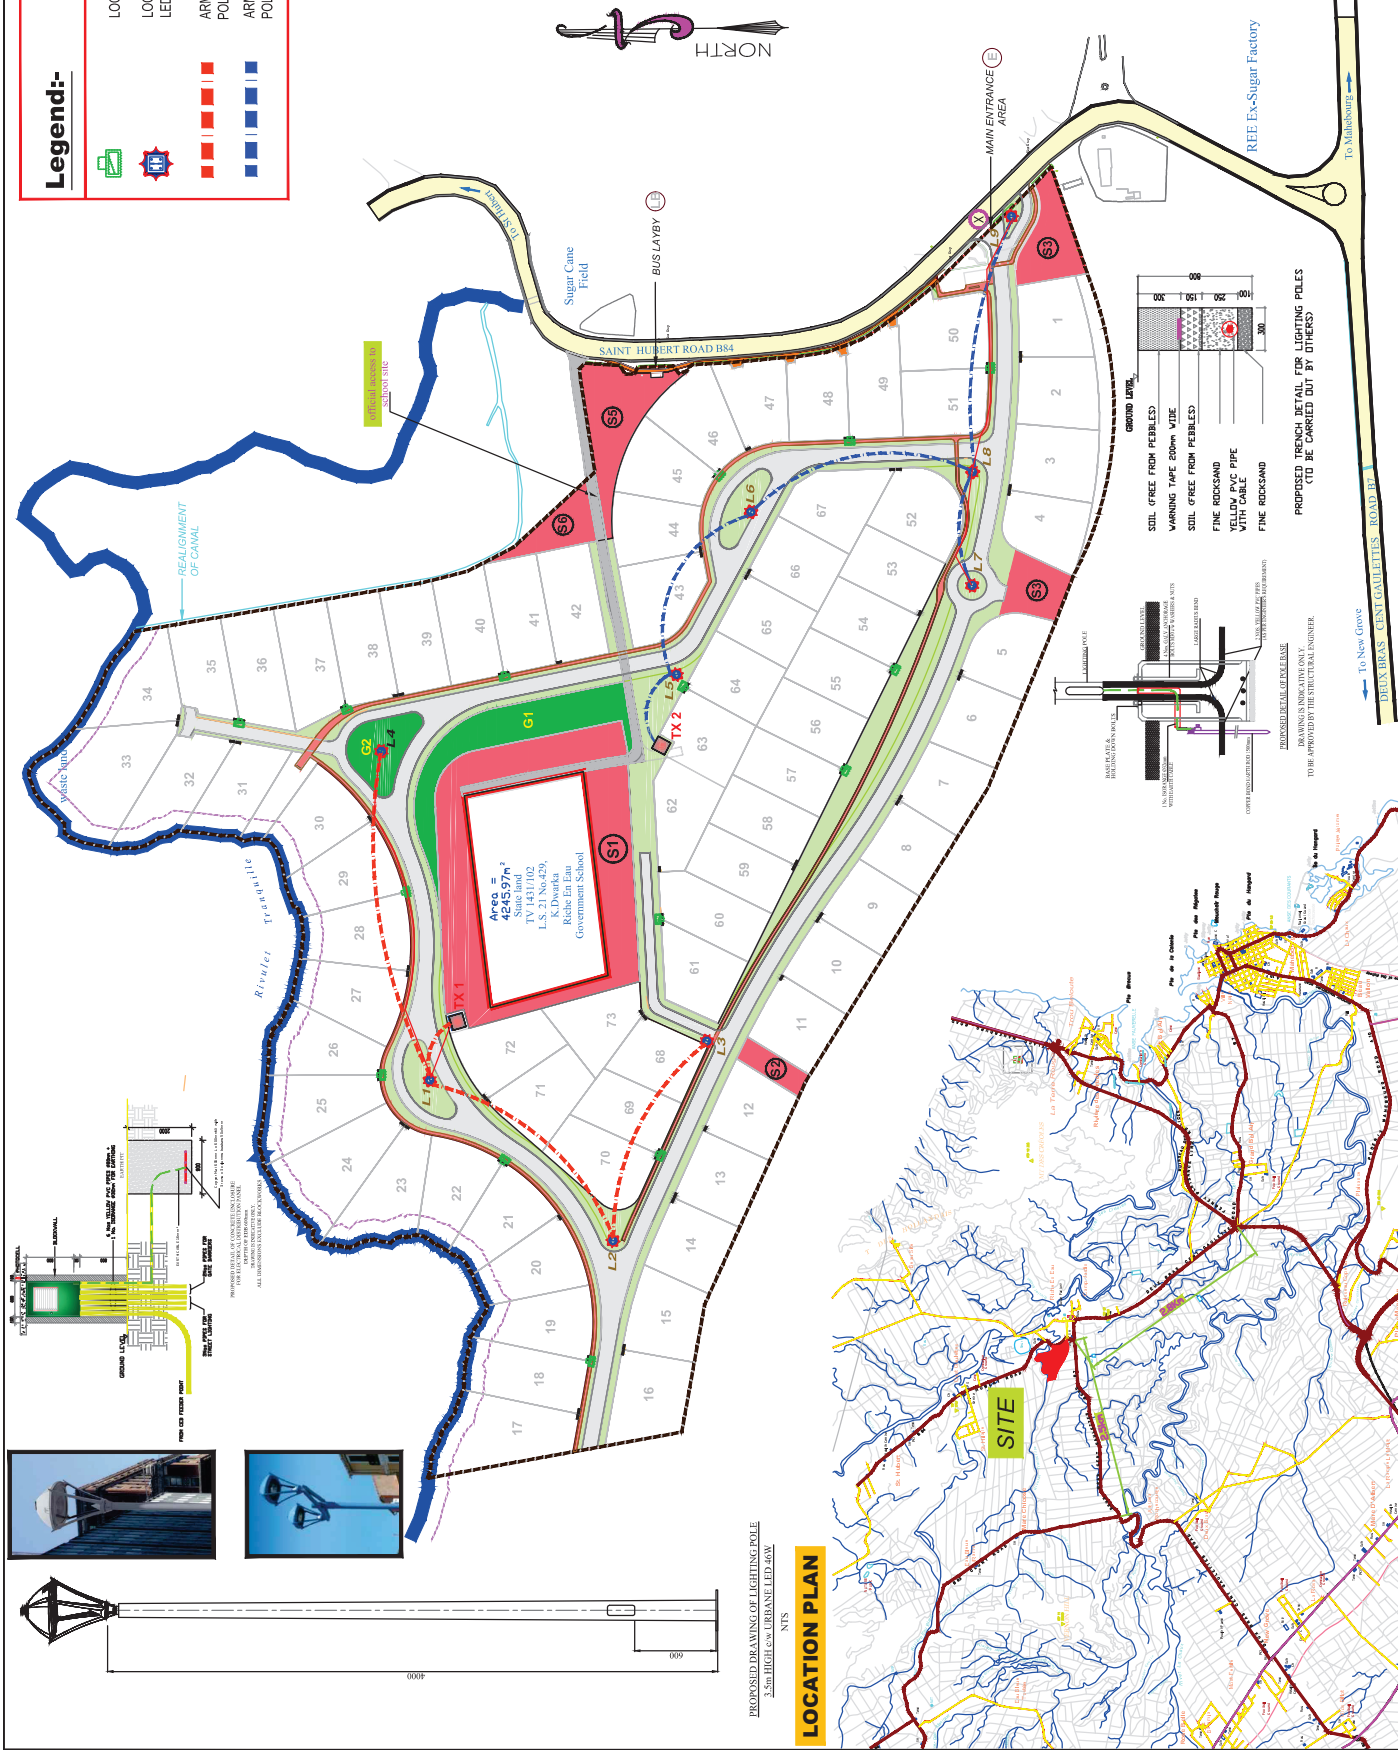
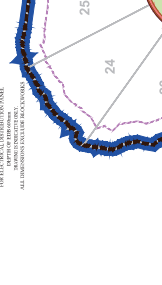


[illegible]

Client: **COMPAGNIE DE
BEAU VALLON LTÉE**

Project:
**Proposed Infrastructural Works
For
Residential Morcellement
At Riche-En-Eau**

Drawing Title:
**Proposed
Street Lighting Layout**

Scale: 1/1000	Paper size: A1	Date: SEPT-2015
Drawg No: KSCDBVREESTL01		
Drawn by: Y.P	Checked by: S.P	

Engineer:

KASELOR LTD
*Consulting Civil, Structural &
Environmental Engineers*

*Project Manager &
Construction Manager*
53, RUE DE LA CANELLE
EBENE CITY
EBENE
MAURITIUS

TEL & FAX: 00 230 465-8154
E-MAIL: kasele@orange.mu
WEB: www.kasele.com
VAT REG. NO: 202716817